 



A:\308 VVF HOSPITAL\DRAWINGS\ARCHITECTURAL\FLOORPLAN-OVERALL.DWG, A-1, 10/1/2007 2:33:20 PM, PDF995.pc3



OVERALL FLOOR PLAN

1:300

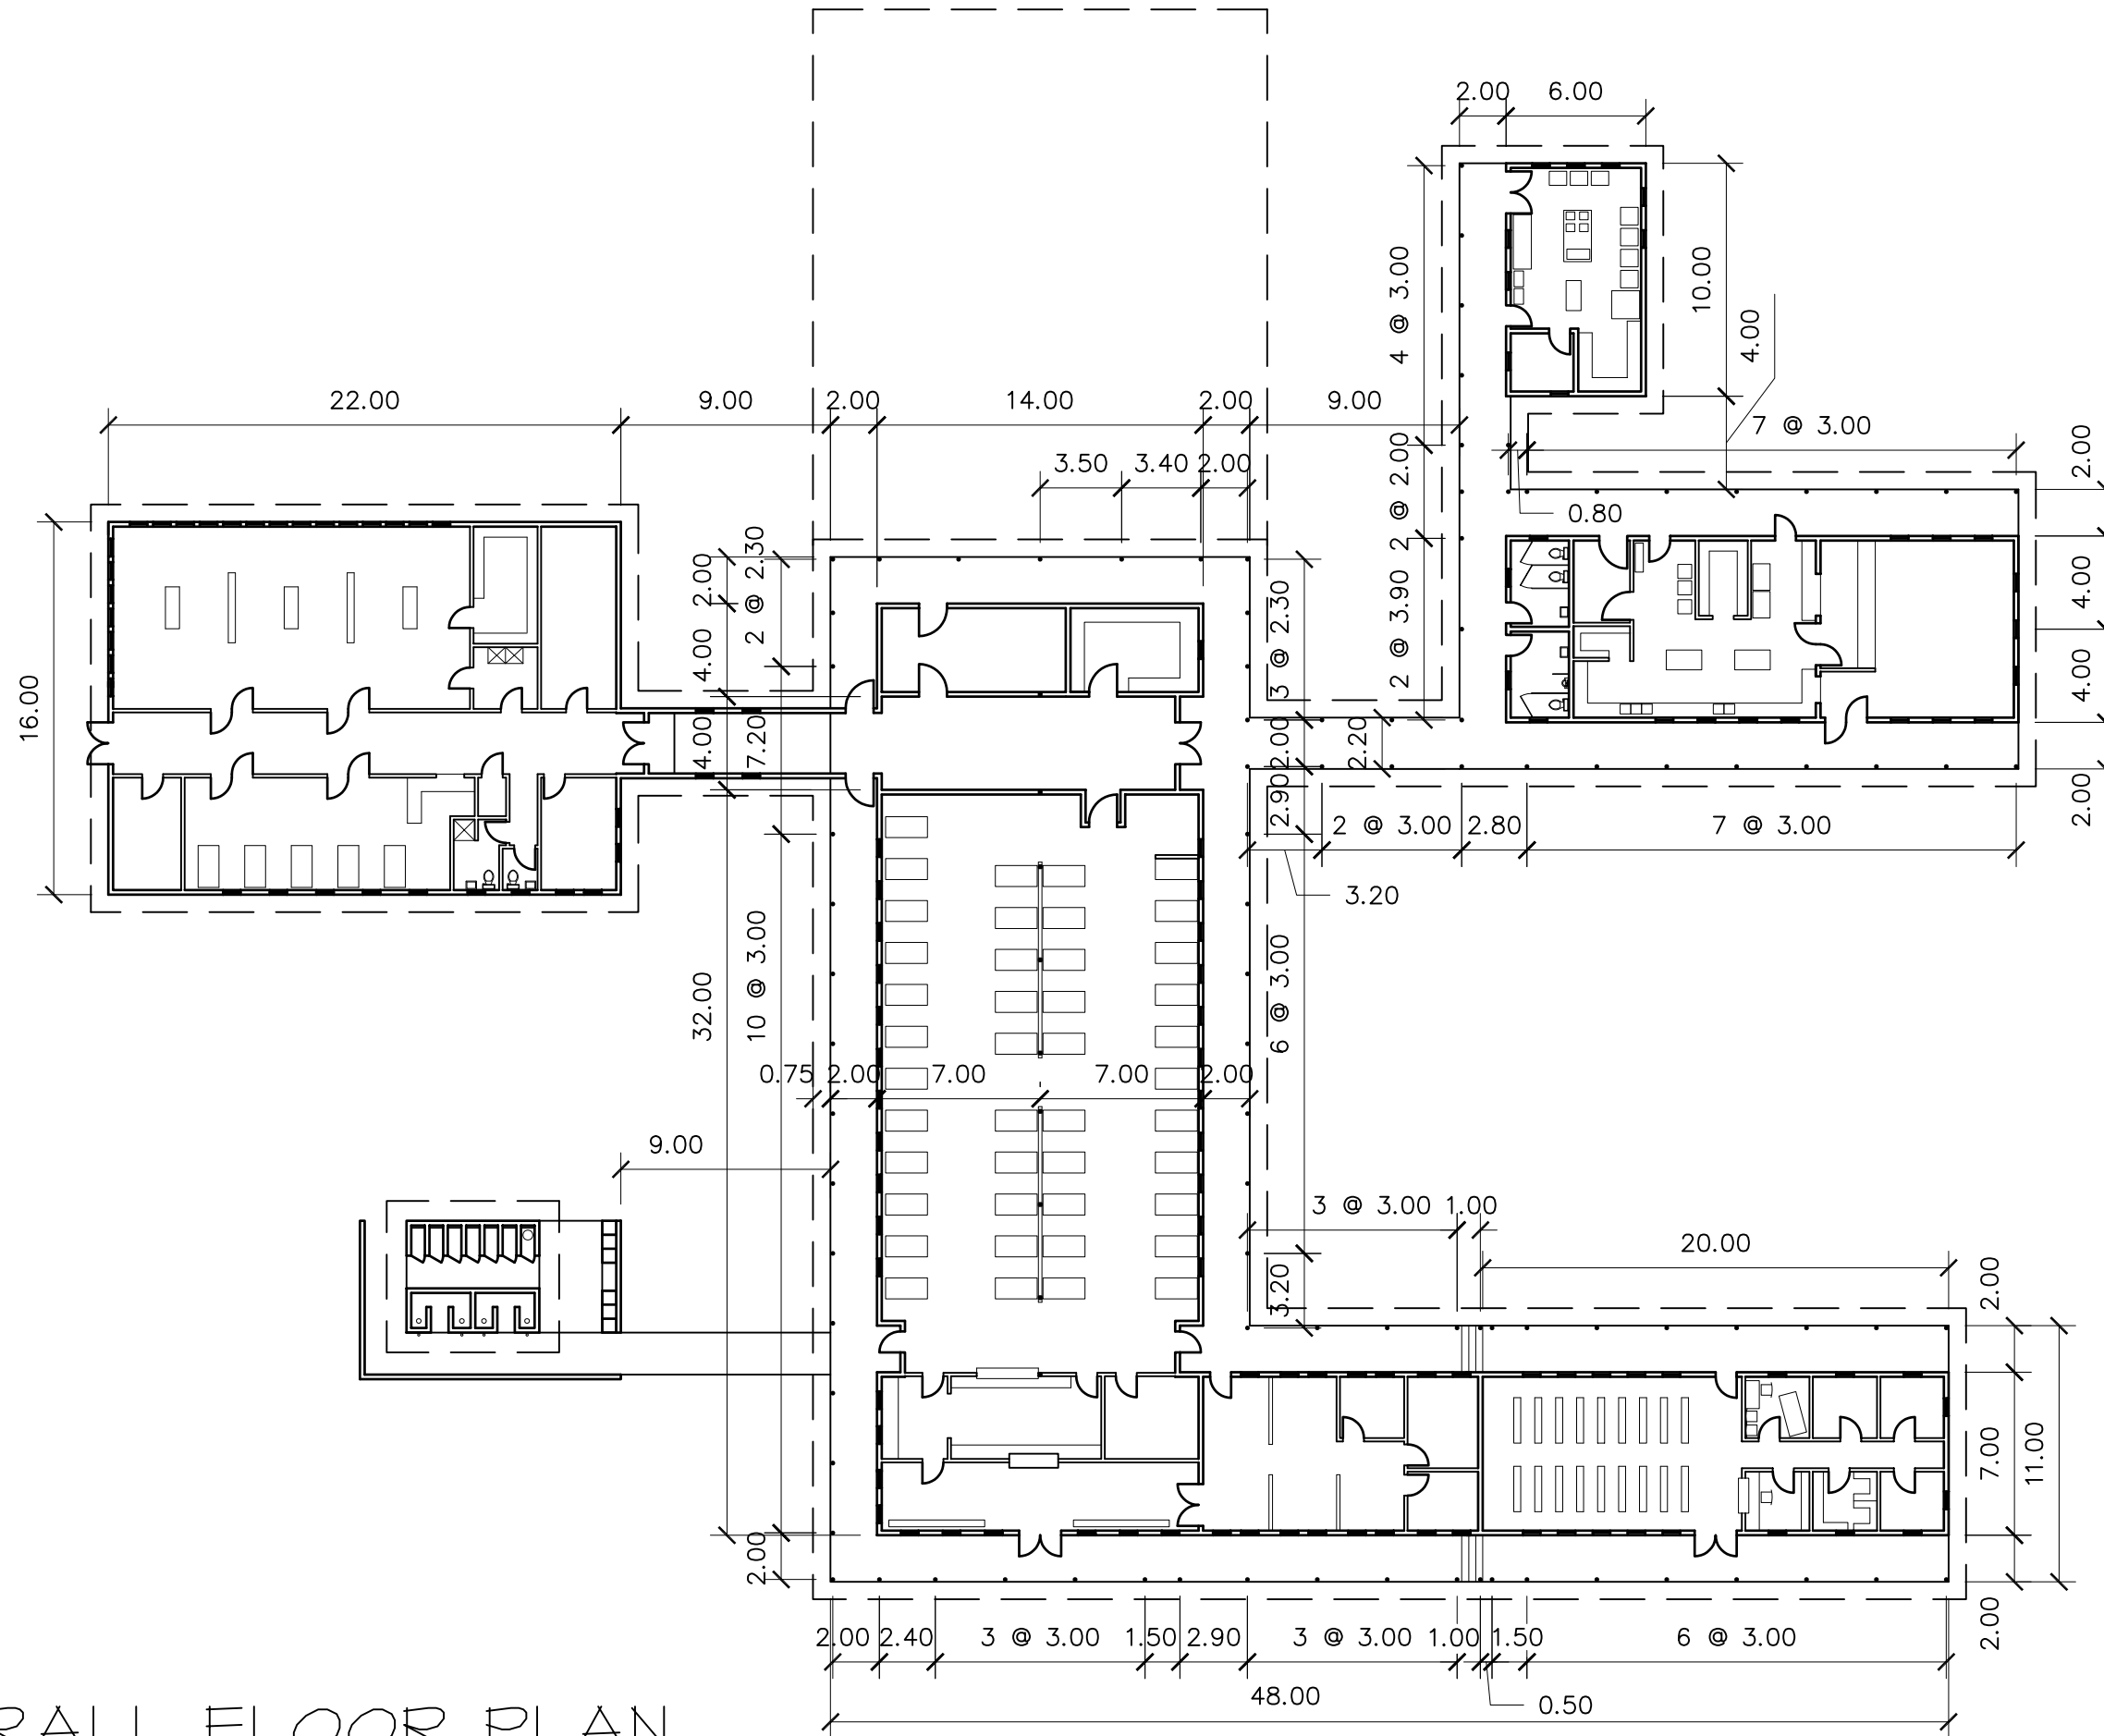

WFMIC VVF HOSPITAL OVERALL FLOOR PLAN

date issued:
09/02/2003

FINAL

project:
5308

scale:
1:300

sheet number

A-1



designing a world of hope
engineering ministries international
110 South Weber, Suite 104, Colorado Springs, CO 80903
phone: 719/633-2078 fax: 719/633-2970 www.emiusa.org